

PCC WEST BUILDING

PCC NORTH BUILDING

AFCI Creativation 2020

AFCI Creativation 2020

January 16 - 20, 2020

Phoenix Convention Center

Phoenix, AZ



Halls 1-2-3-4-5-6

Legend

TOTAL BOOTH COUNT:

Inventory as of 04/10/2019

Dimension	Size	Qty	SqFt
10'x10'	100	1,151	115,100
20'x20'	400	1	400
30'x60'	1,800	1	1,800
50'x80'	4,000	2	8,000
Totals:		1,155	125,300

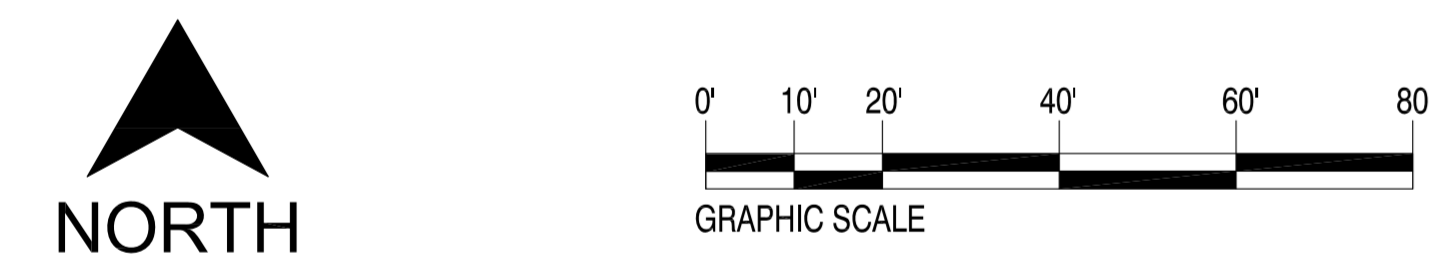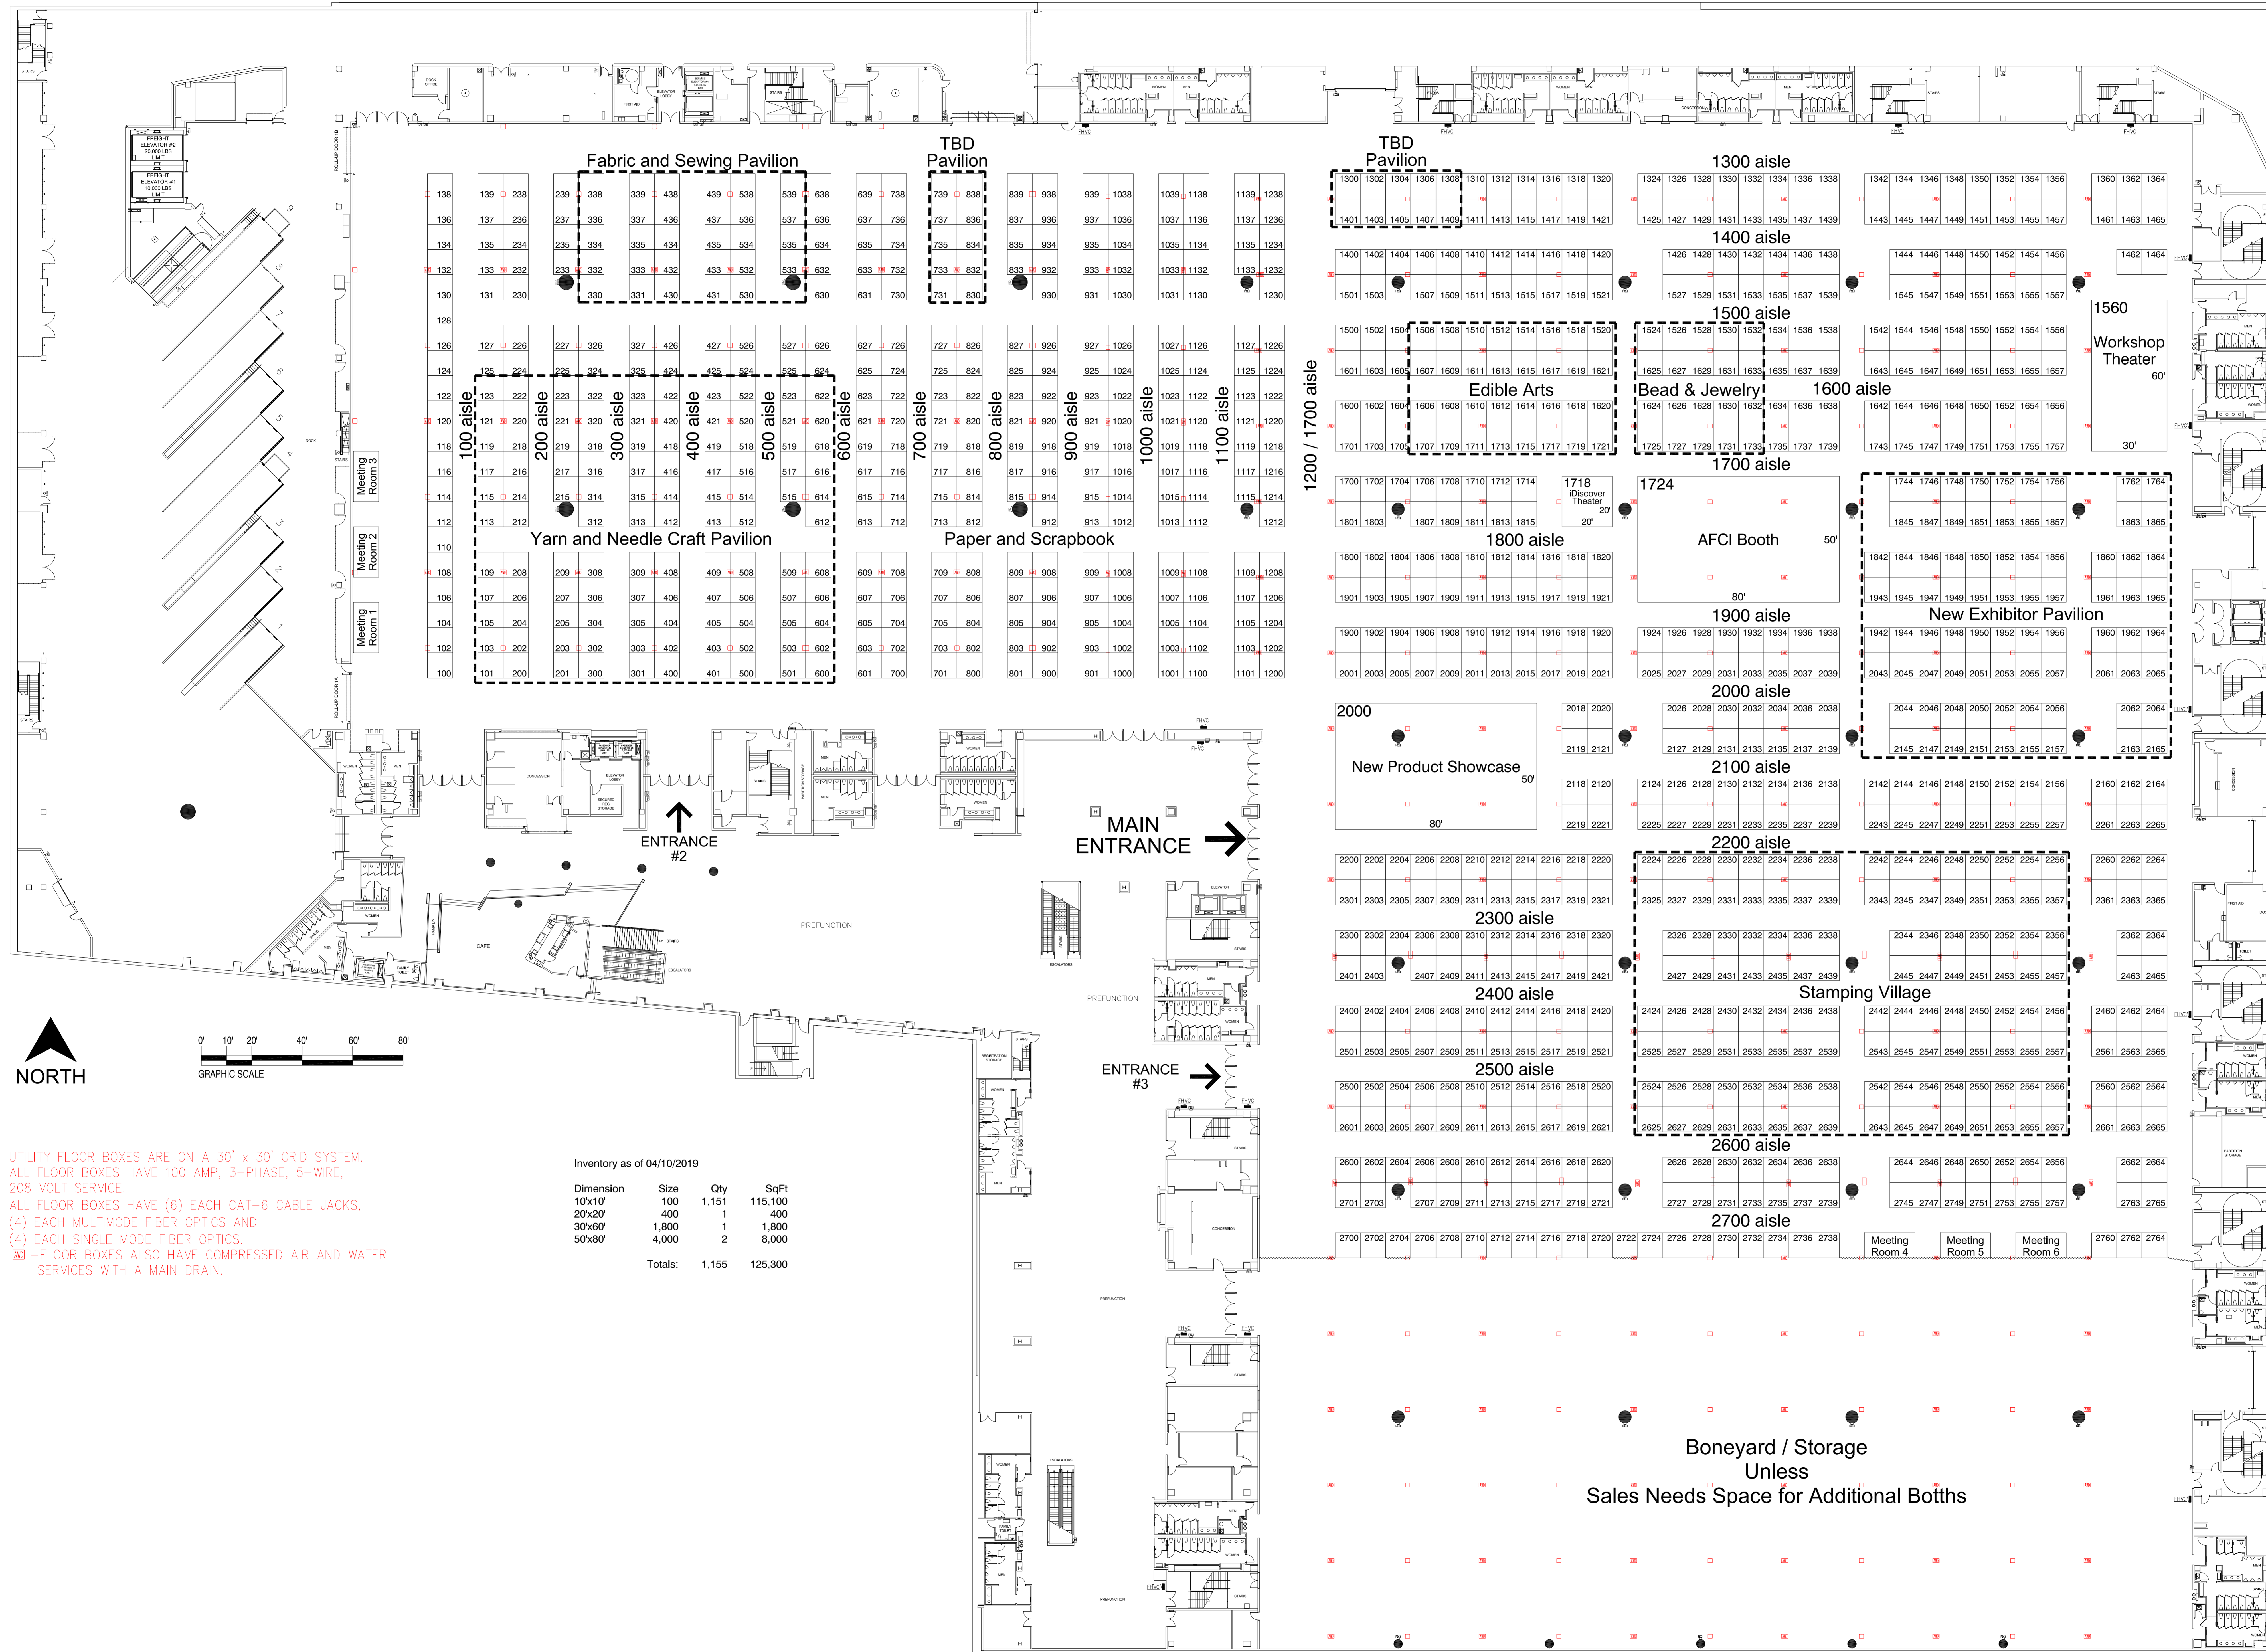

UTILITY FLOOR BOXES ARE ON A 30' x 30' GRID SYSTEM.
 ALL FLOOR BOXES HAVE 100 AMP, 3-PHASE, 5-WIRE, 208 VOLT SERVICE.
 ALL FLOOR BOXES HAVE (6) EACH CAT-6 CABLE JACKS, (4) EACH MULTIMODE FIBER OPTICS AND (4) EACH SINGLE MODE FIBER OPTICS.
 FLOOR BOXES ALSO HAVE COMPRESSED AIR AND WATER SERVICES WITH A MAIN DRAIN.

Inventory as of 04/10/2019

Dimension	Size	Qty	SqFt
10'x10'	100	1,151	115,100
20'x20'	400	1	400
30'x60'	1,800	1	1,800
50'x80'	4,000	2	8,000
Totals:		1,155	125,300

AE: Taylor, Sara

Show Number: 11845-20-20_AFCI

Drawn By: Bob Koenig

Revised: 4/10/19

File: 11845-20-20_afci r4 4-10-19.dwg

Every effort has been made to ensure the accuracy of all information contained on this floor plan. However, no warranties, either expressed or implied are made with respect to this floor plan. If the location of building columns, utilities or other architectural components of the facility is a consideration in the construction of an exhibit, it is the sole responsibility of the exhibitor to physically inspect the facility to verify all dimensions and locations.